




Electrical Contractors

- 1834 Woods Drive
Dayton, OH 45432
- p 937 431 9363
- f 937 431 9364
- www.mnelectric.biz

PRESTIGE PLAZA - SUITE 107

8 PRESTIGE PLAZA DR SUITE 108, MIAMISBURG, OH 45342

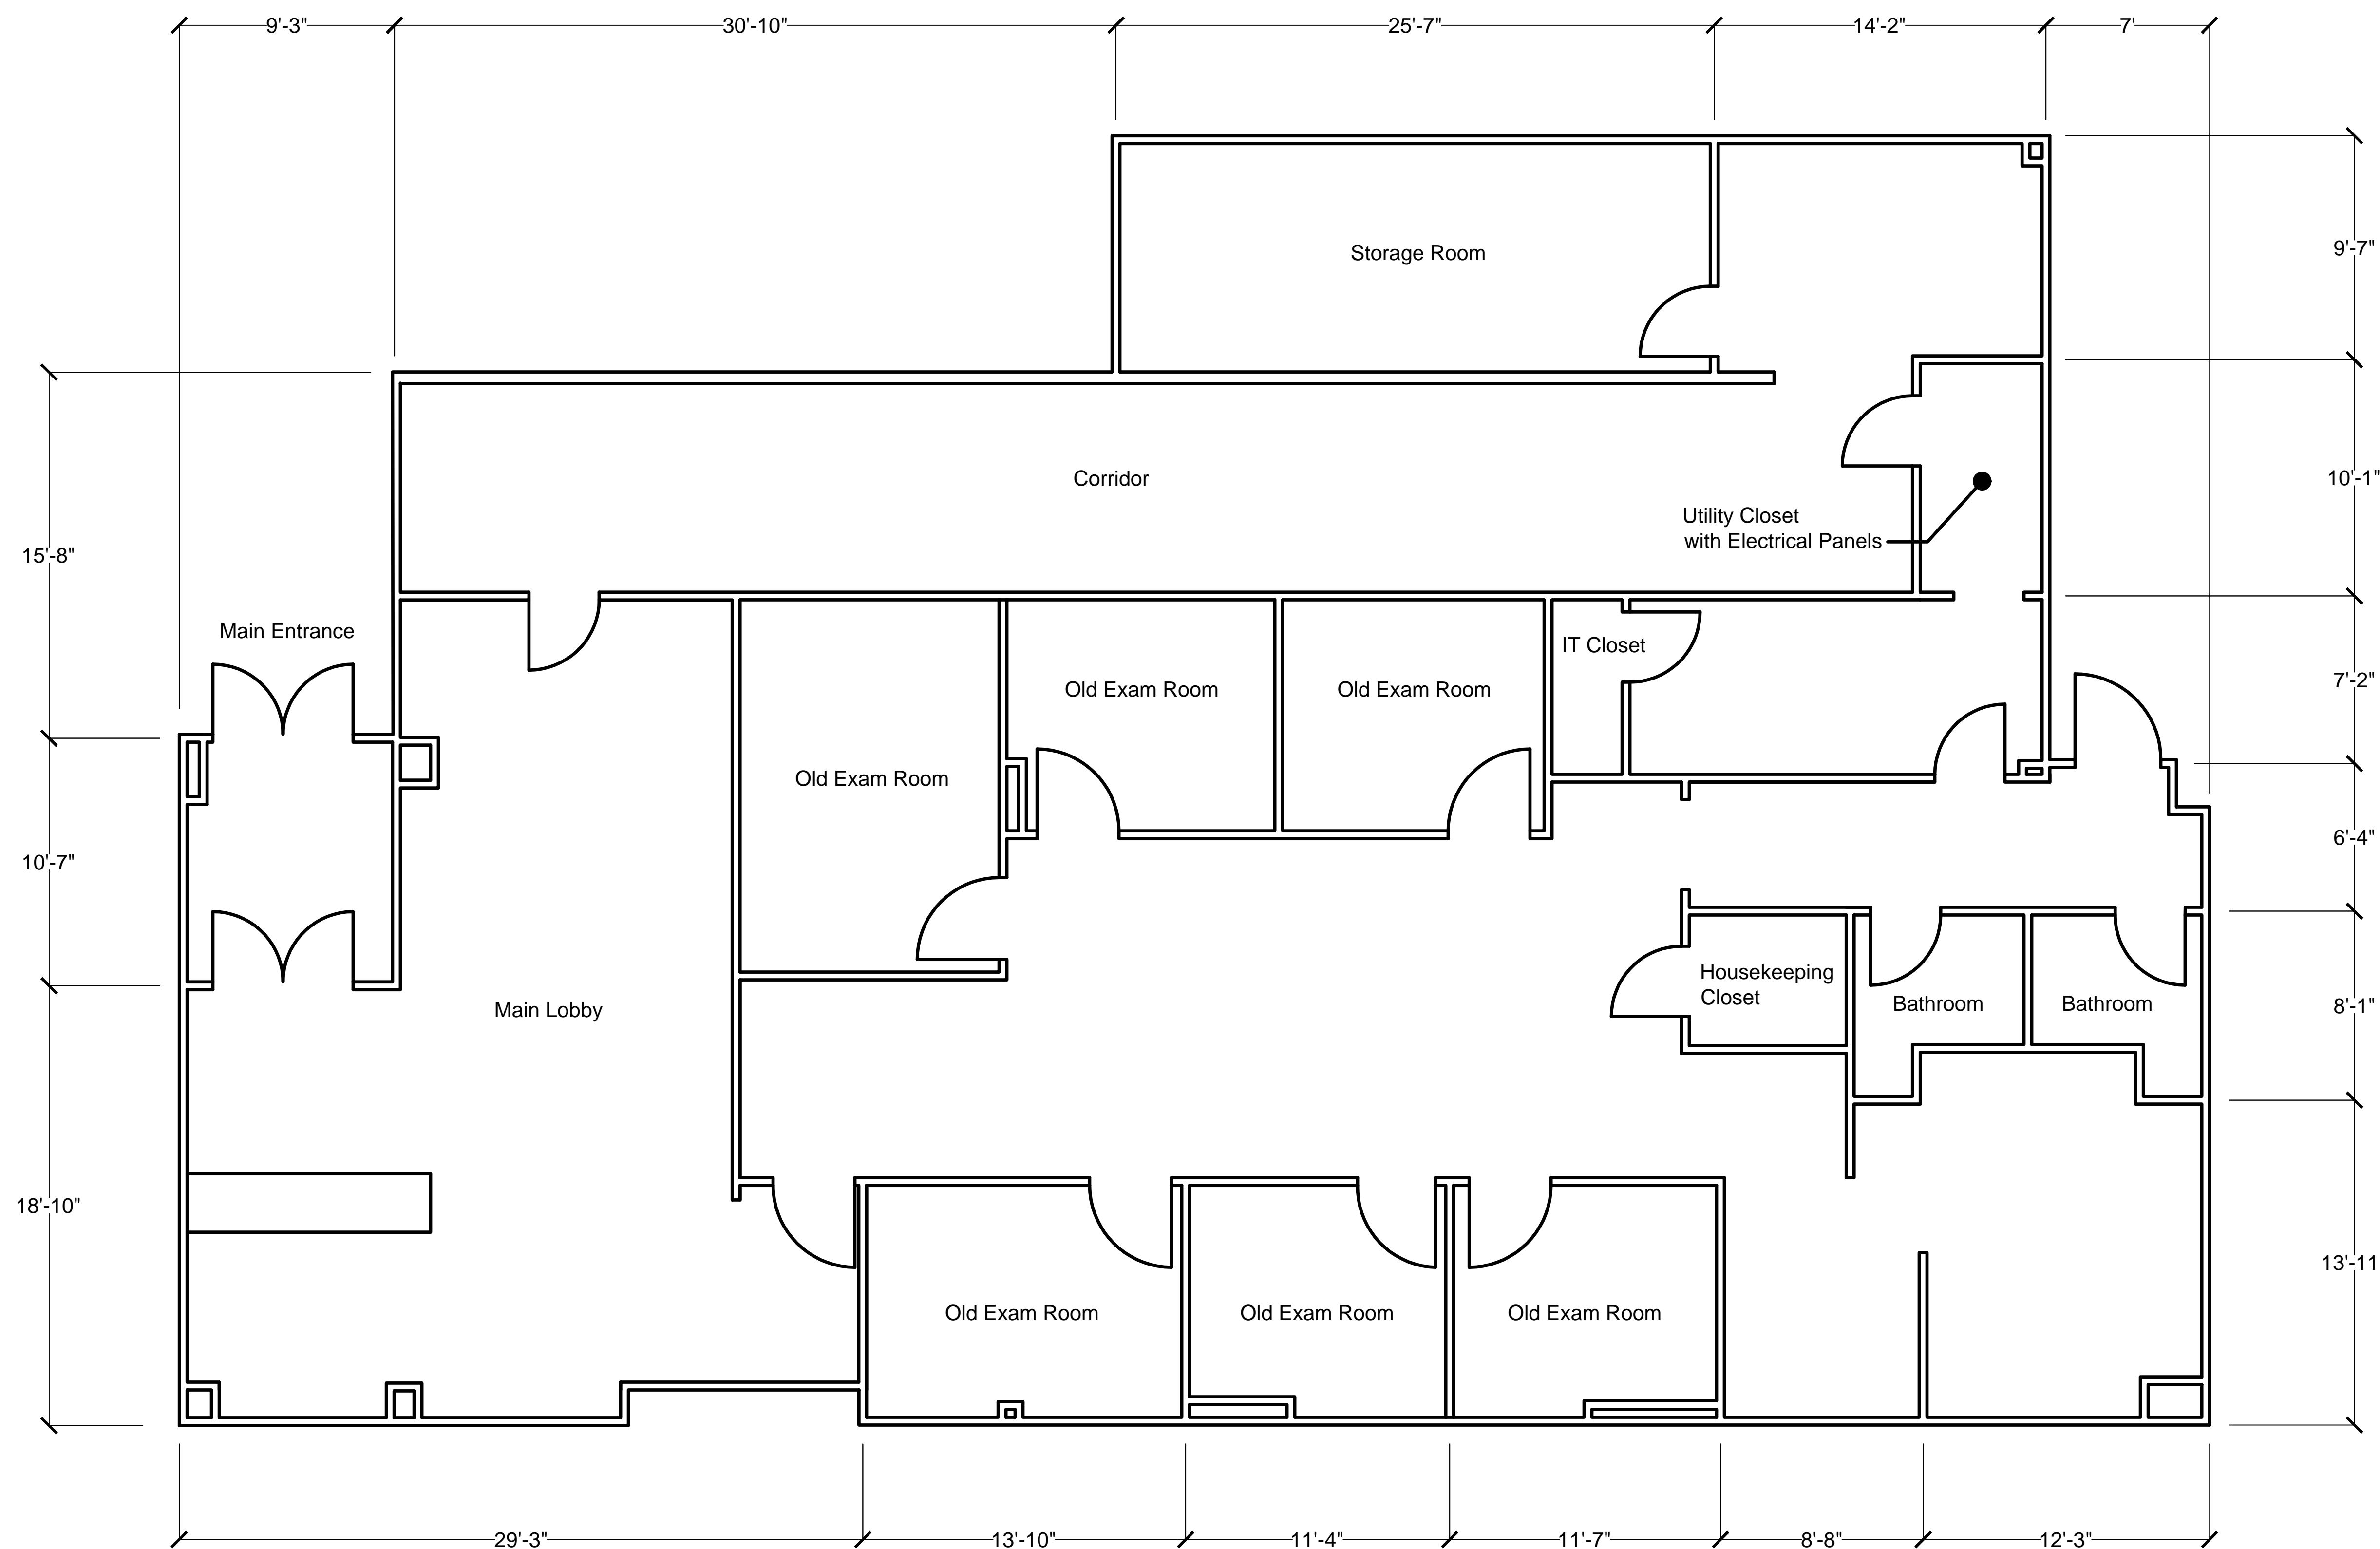

OVERALL FLOOR PLAN | 1
1/4" = 1' | E101

STATUS:

REVISION:

PROJECT NUMBER:

DATE:

3 OCTOBER 2024

SHEET NAME:

FLOOR PLAN

SHEET NUMBER:

E1.0