



SECTION "A-A"
SCALE: 1" = 50'

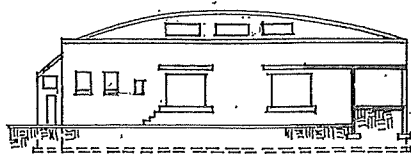

SECTION "B-B"
SCALE: 1" = 50'

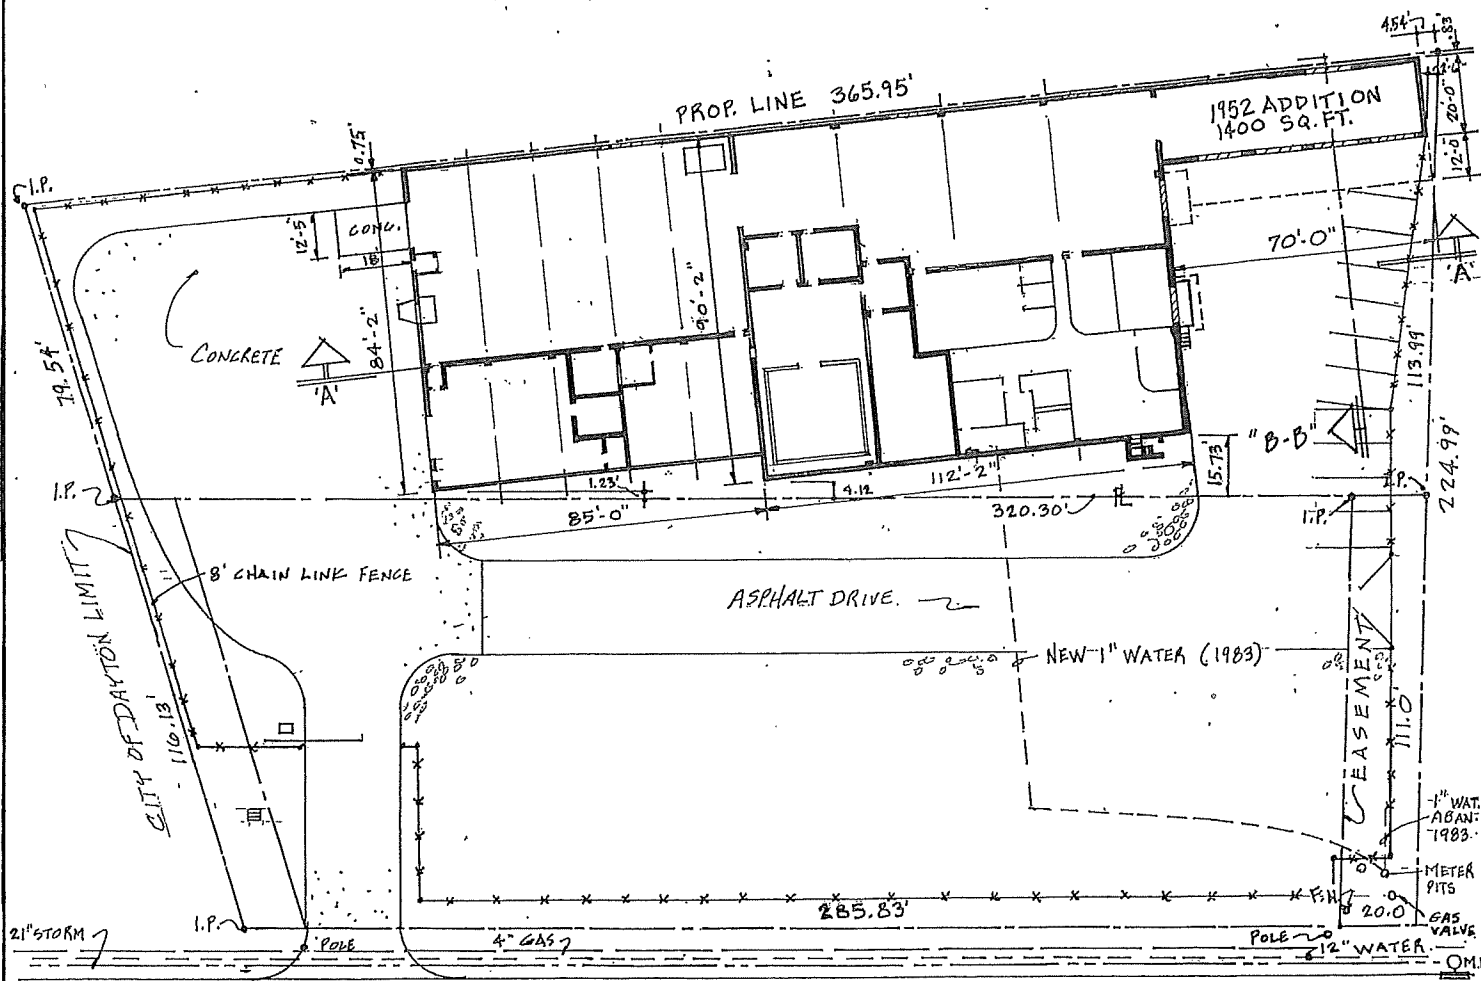

SPRINGFIELD STREET

10" WATER
SANITARY SEWER

FLOOR PLAN

SCALE: 1" = 50'

REVISE	THE DAYTON HYDRAULIC COMPANY	
3-30-79	4395 SPRINGFIELD ST., DAYTON	
1-25-83	BUILDING NUMBER : 03	
2-21-83		
1-21-91		
1-8-93		